



ARCHITECTURAL SOLUTIONS

SYNERGY



Kevin Shotter BA DipArch ARB ACA
W: www.synergy-as.co.uk
E: kevin@synergy-as.co.uk
T: 01548 810780 M: 07749 525591

Project			
Kingston Reading Room			
Drawing Title			
Proposed First Floor Plan			
Drawing Status			
Planning			
Scale	Paper Size	Date	Drawn
1:100	A3	10.05.21	KJS
Job No.	Drawing Number	Rev.	
S2008	12	F	

Rev A: Additional redesigned following pre-app meeting - 18 Oct 2021
 Rev B: Existing foul water drainage runs & buried manhole added following site investigation - 14 July 2021
 Rev C: Proposals redesigned following pre-app site meeting - 18 Oct 2021
 Rev D: Proposals amended in accordance with pre-app feedback - 02 Nov 2021
 Rev E: Toilet windows added - 16 Nov 2021
 Rev F: Minor amendments & new fencing added - 23 Nov 2021

© Copyright Synergy Architectural Solutions
All rights reserved

Note:
DO NOT SCALE from this drawing. Please contact this office for any additional information required.
 Contractors, Sub-Contractors and Suppliers must check all relevant dimensions and levels of the site and building before commencing any workshop drawings or building work. Any discrepancies should be recorded to the Office.
 Where applicable this drawing is to be read in conjunction with the Consultants' drawings.

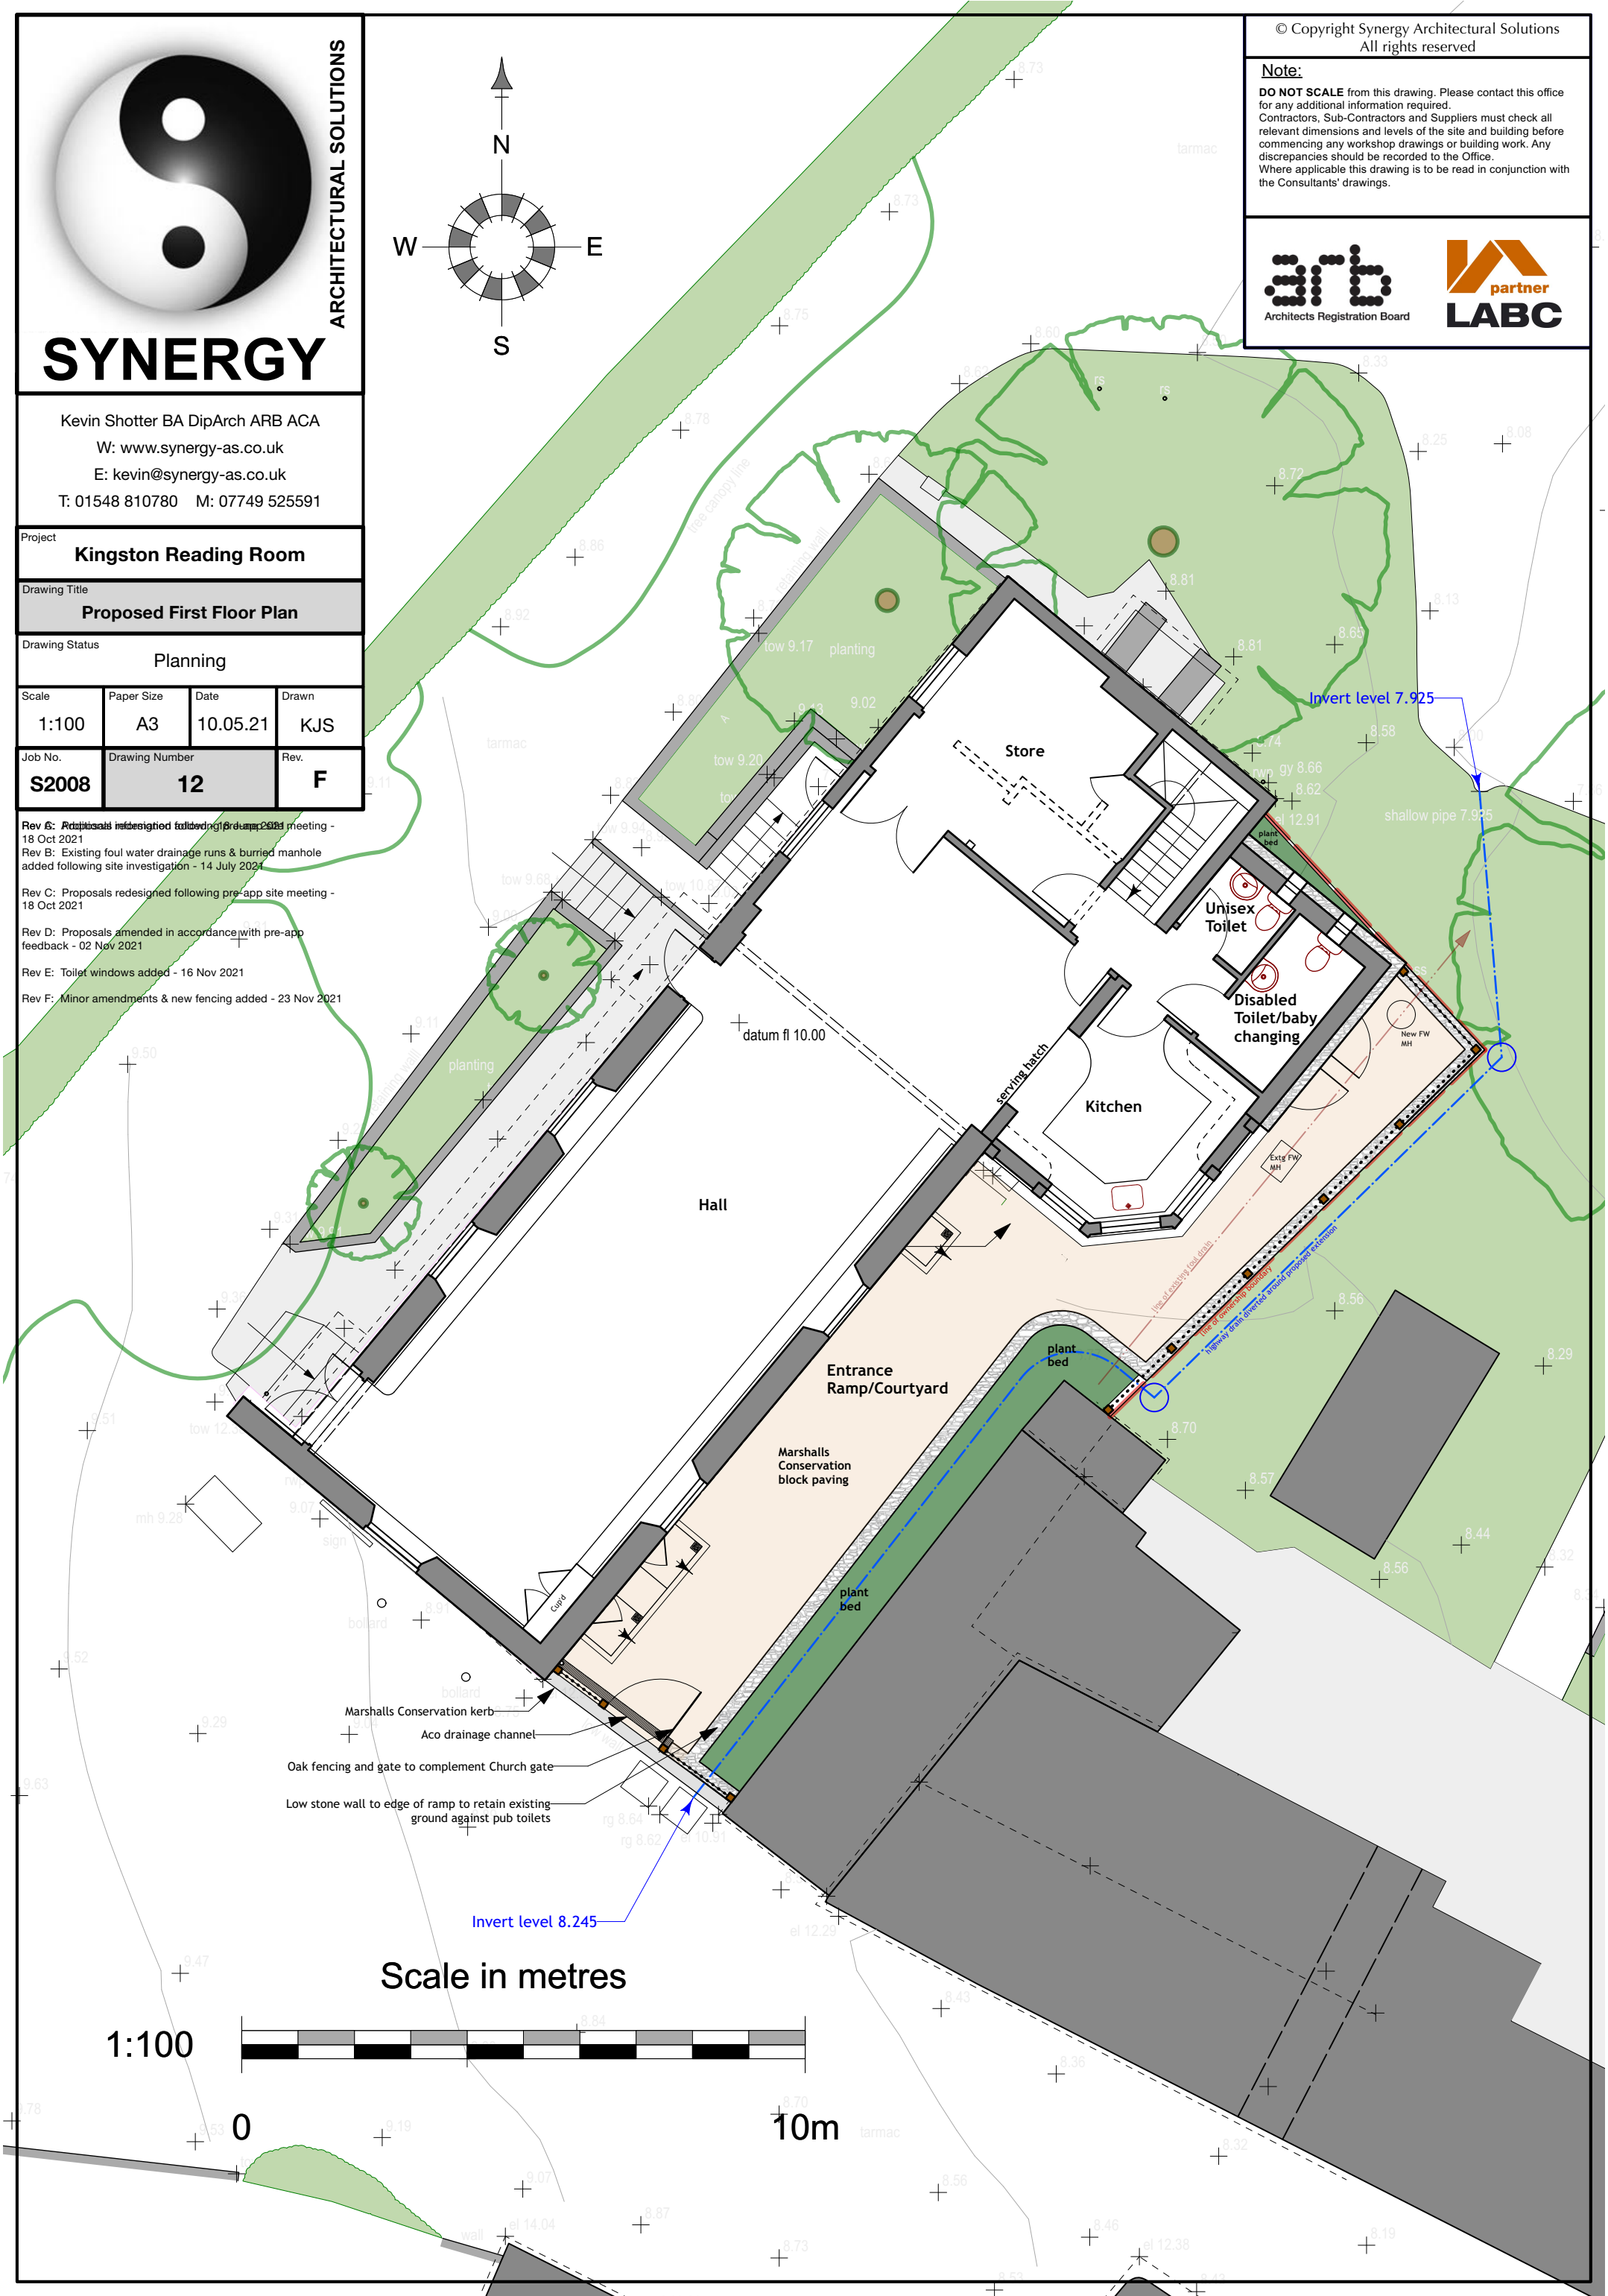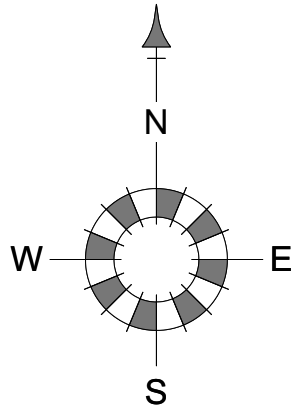

Scale in metres

1:100



10m