



ARCHITECTURAL SOLUTIONS

# SYNERGY

W: [www.synergy-as.co.uk](http://www.synergy-as.co.uk)  
E: [kevin@synergy-as.co.uk](mailto:kevin@synergy-as.co.uk)  
T: 01548 810780 M: 07749 525591

Project: **Kingston Reading Room**


Drawing Title: **Ground Floor Plan Sketch A**

Drawing Status: **Feasibility**

Scale	Paper Size	Date	Drawn
1:100	A3	21.11.20	KJS

Job No.	Drawing Number	Rev.
S2008	SKA-GF	~


Rev:

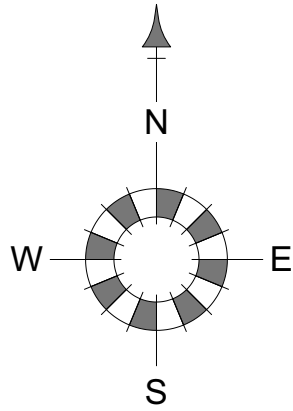

© Copyright Synergy Architectural Solutions  
All rights reserved

**Note:**

**DO NOT SCALE** from this drawing. Please contact this office for any additional information required. Contractors, Sub-Contractors and Suppliers must check all relevant dimensions and levels of the site and building before commencing any workshop drawings or building work. Any discrepancies should be recorded to the Office. Where applicable this drawing is to be read in conjunction with the Consultants' drawings.

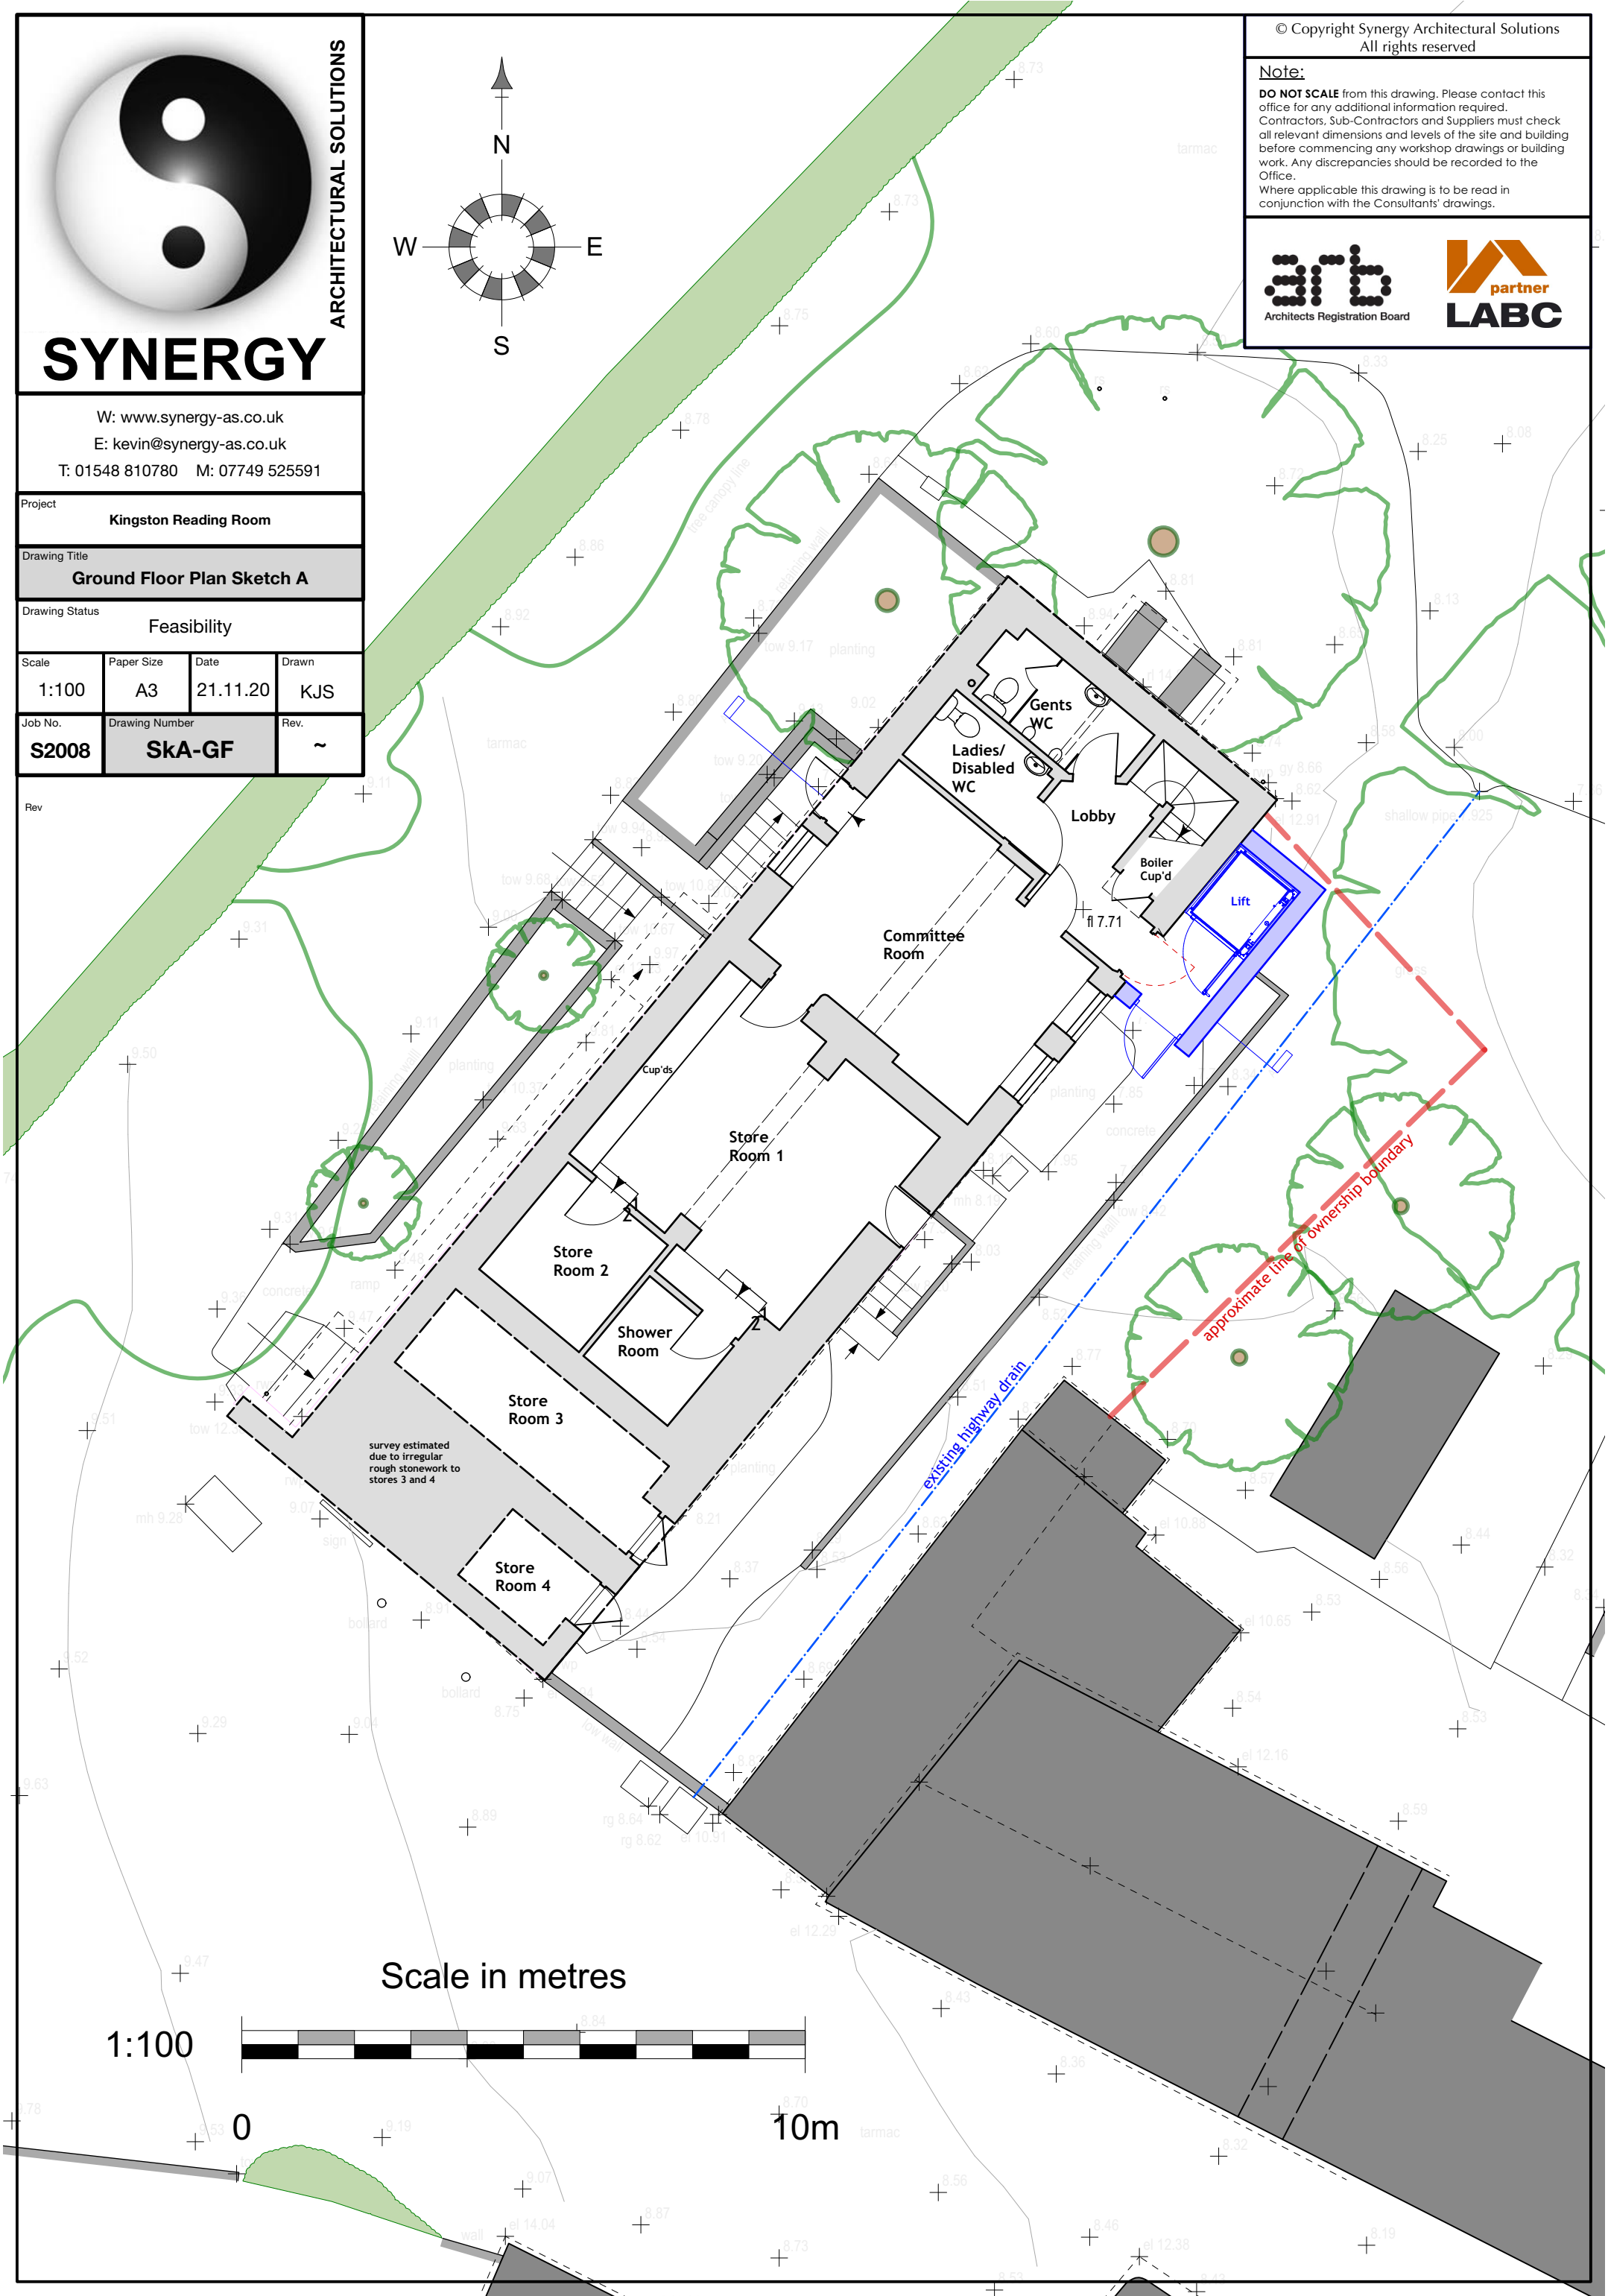

Scale in metres

1:100



0

10m