




ARCHITECTURAL SOLUTIONS

# SYNERGY

W: [www.synergy-as.co.uk](http://www.synergy-as.co.uk)  
E: [kevin@synergy-as.co.uk](mailto:kevin@synergy-as.co.uk)  
T: 01548 810780 M: 07749 525591

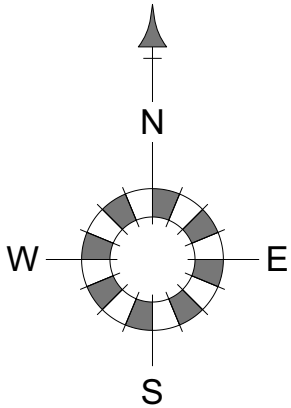

© Copyright Synergy Architectural Solutions  
All rights reserved


**Note:**

**DO NOT SCALE** from this drawing. Please contact this office for any additional information required. Contractors, Sub-Contractors and Suppliers must check all relevant dimensions and levels of the site and building before commencing any workshop drawings or building work. Any discrepancies should be recorded to the Office. Where applicable this drawing is to be read in conjunction with the Consultants' drawings.



Project <b>Kingston Reading Room</b>			
Drawing Title <b>First Floor Plan Sketch C</b>			
Drawing Status <b>Feasibility</b>			
Scale <b>1:100</b>	Paper Size <b>A3</b>	Date <b>21.11.20</b>	Drawn <b>KJS</b>
Job No. <b>S2008</b>	Drawing Number <b>SkC - FF</b>	Rev. <b>~</b>	

Rev.	
------	--

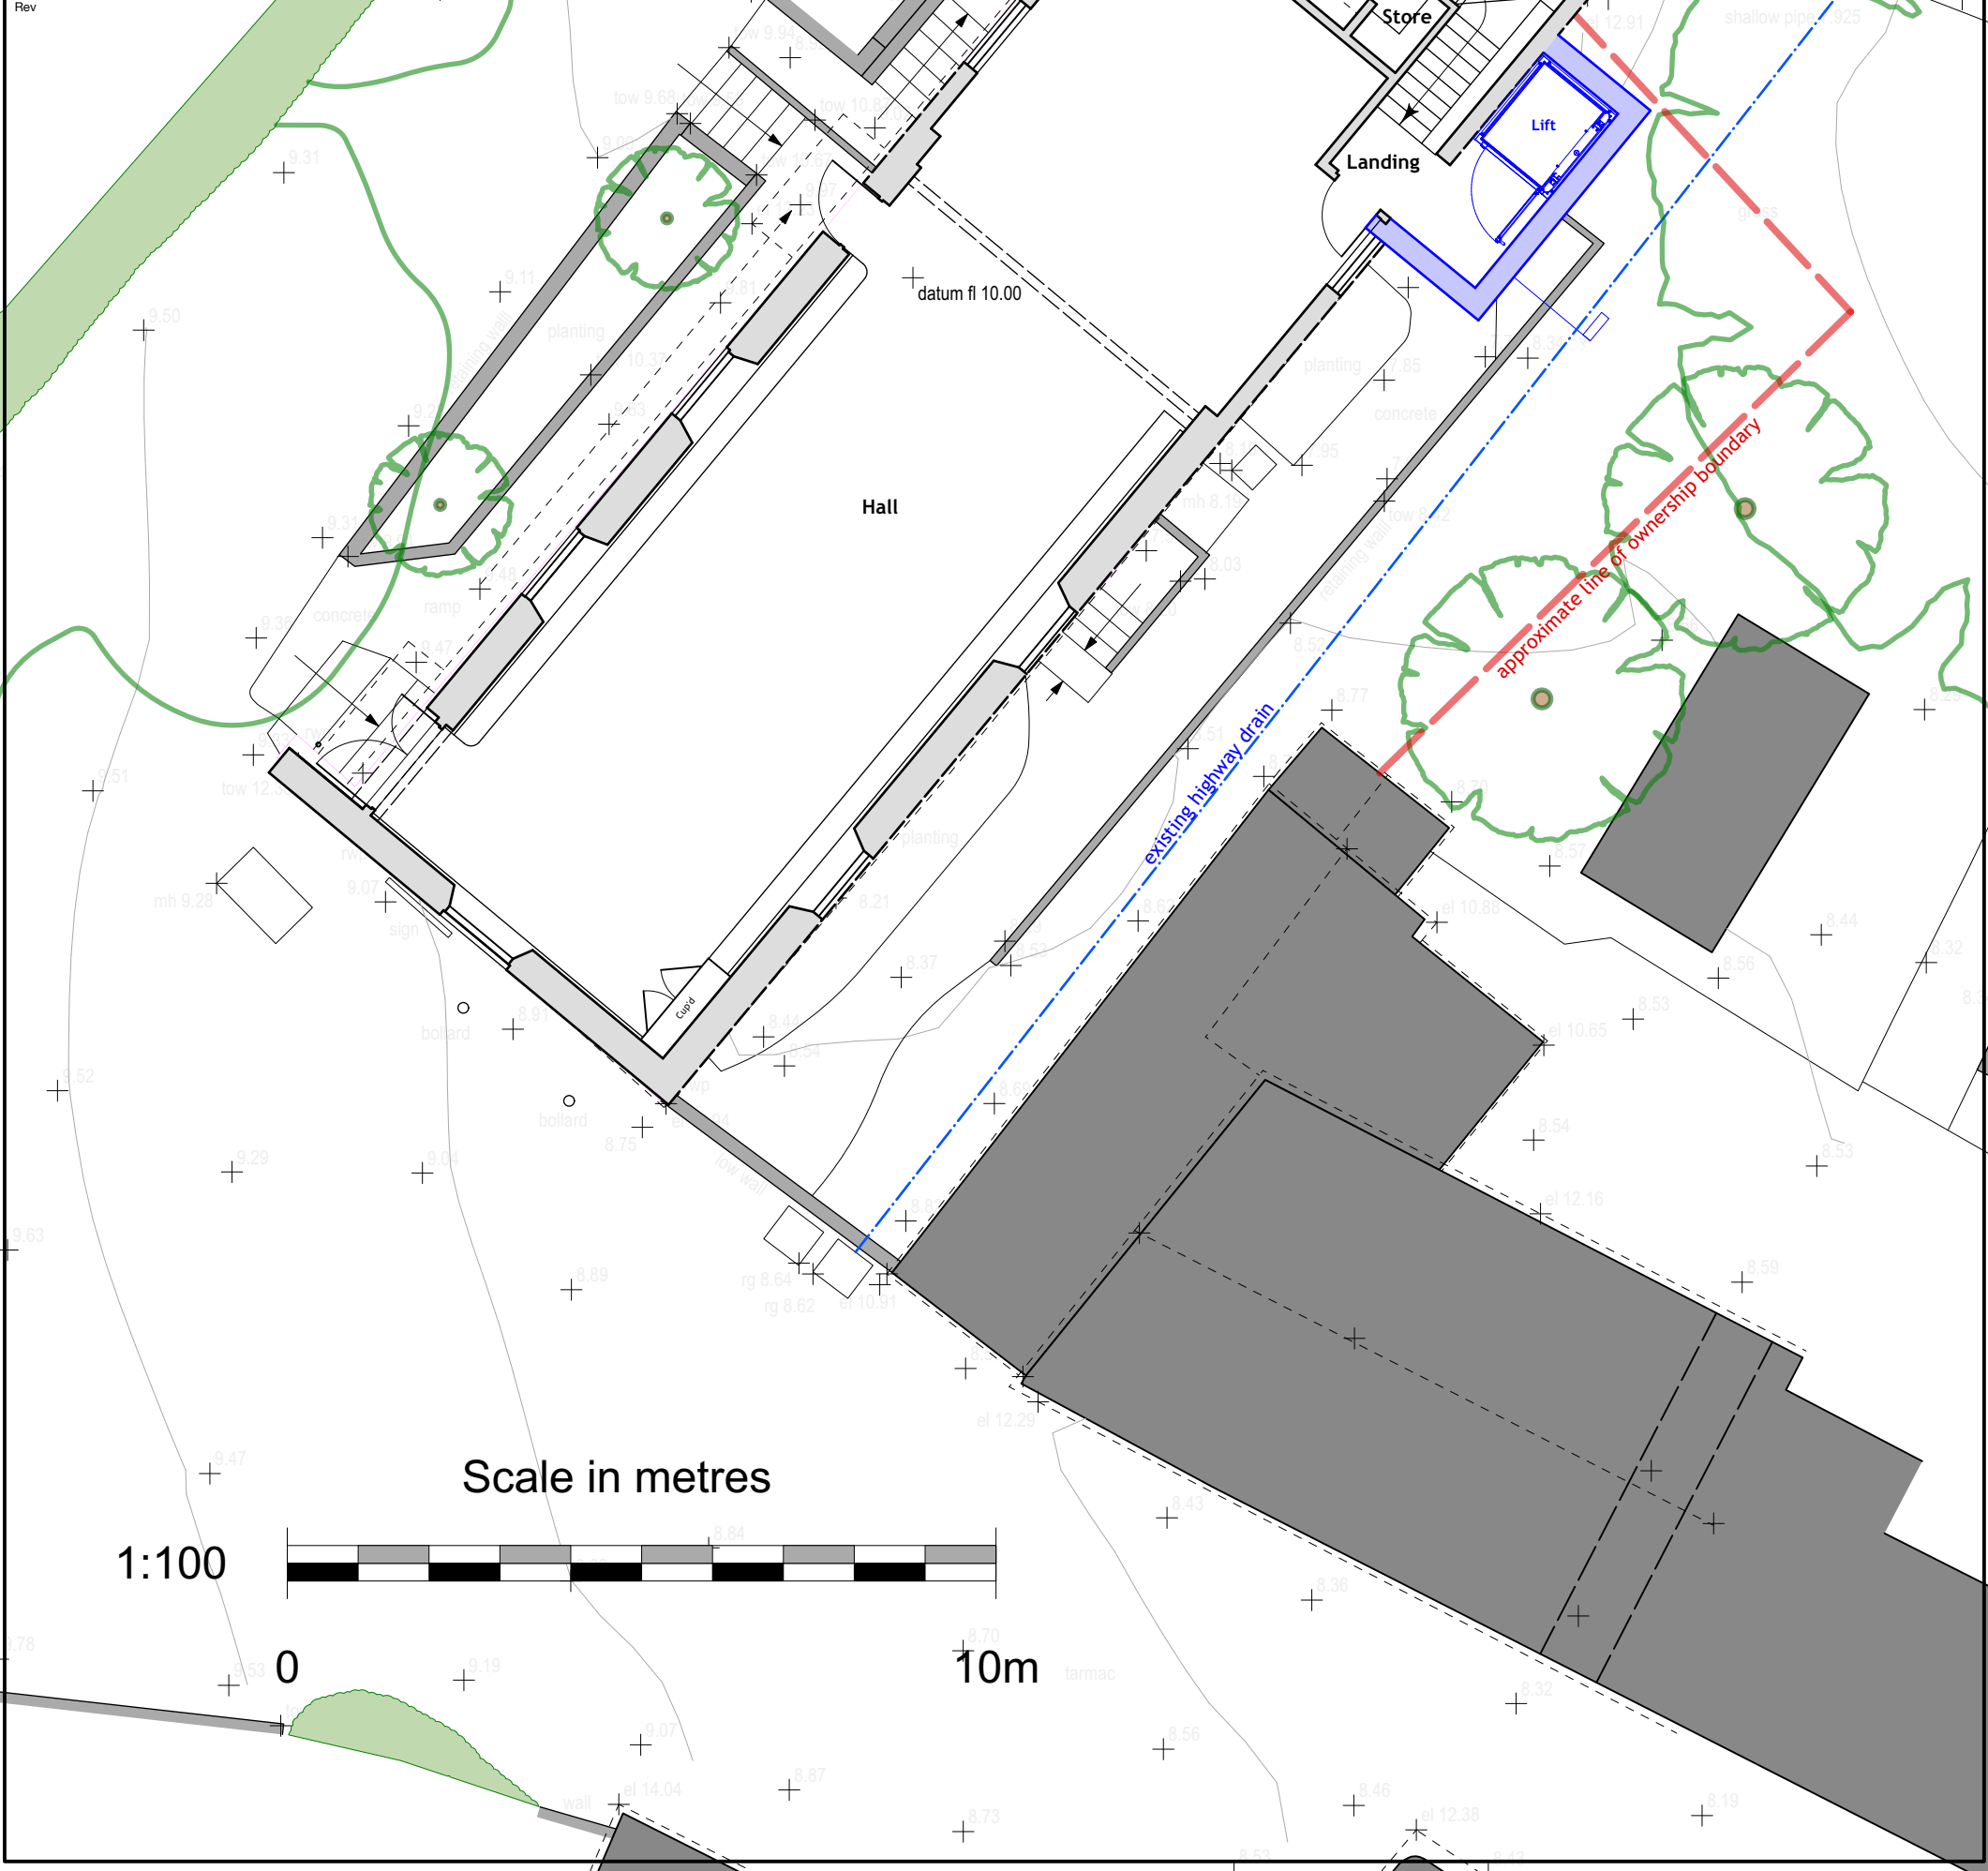

Scale in metres

